

3D SKETCH VIEW OF VERSION 1 WAITING LOUNGE

SHEET TITLE: 3D VIEW V1

SHEET

REV

REVISION #:

ISSUED:

PROJECT #:

31/10/22

#P/n

1

## S & A Ting

### Wgtn Braces Waiting Lounge

121 Thorndon Quay  
Wellington

ALL DIMENSIONS ARE TO BE VERIFIED  
ON SITE. CONSTRUCTION TO COMPLY  
WITH CURRENT NZ BUILDING CODE &  
NZS:3604. OWNERSHIP OF PLANS AND  
DESIGN COPYRIGHT BELONGS TO  
ENCOMPASS GROUP LTD (T/A  
ENCOMPASS IDEAS INTERIOR DESIGN)  
UNTIL ALL PLANS ARE PAID FOR.

ENCOMPASS IDEAS  
INTERIOR DESIGN


Simone van der Plas PDINZ

28 Arcus Rd RD2 Te Horo  
Otaki 5582

PHONE: 021 5 999 55

simone@eideas.co.nz

www.eideas.co.nz

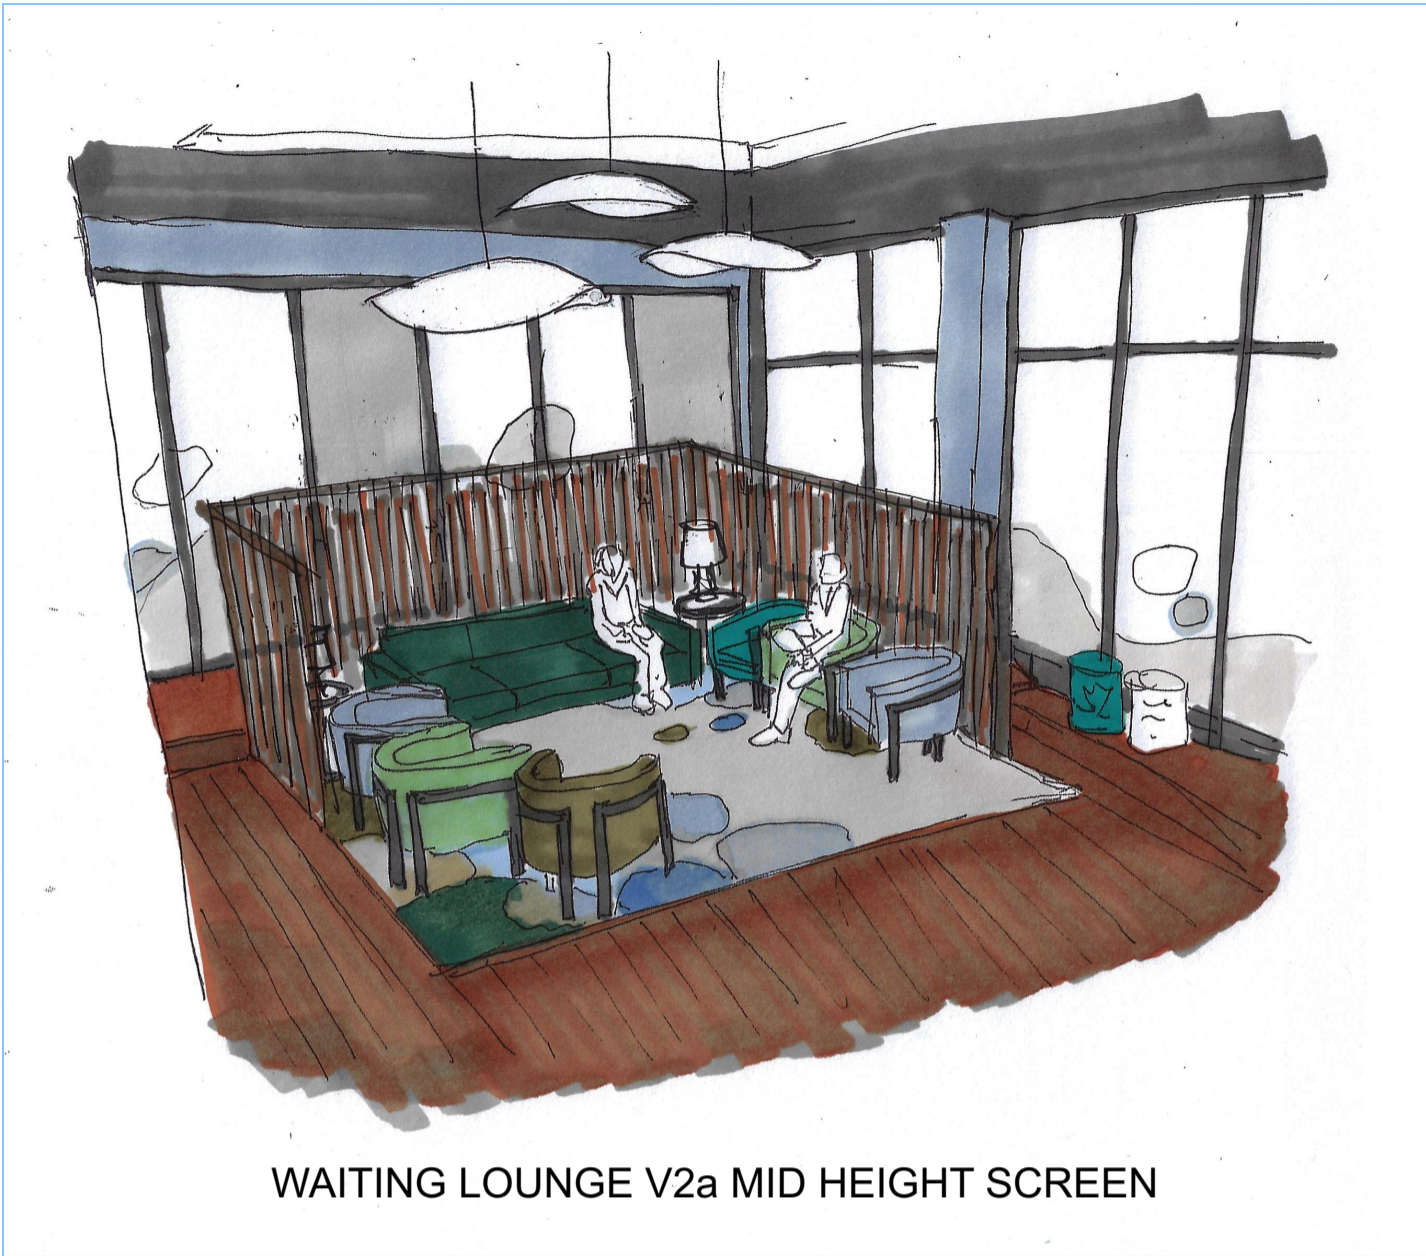

WAITING LOUNGE V2a MID HEIGHT SCREEN



WAITING LOUNGE V2 LOW HEIGHT SCREEN

ENCOMPASS IDEAS INTERIOR  
DESIGN  
Simone van der Plas PDINZ  
28 Arcus Rd, RD2 Te Horo  
Otaki 5582  
PHONE: 021 5 999 55  
simone@eideas.co.nz  
www.eideas.co.nz

ALL DIMENSIONS ARE TO BE  
VERIFIED ONSITE.  
CONSTRUCTION TO COMPLY  
WITH CURRENT NZ BUILDING  
CODE & NZS:3604. OWNERSHIP  
OF PLANS AND DESIGN  
COPYRIGHT BELONGS TO  
ENCOMPASS GROUP LTD (T/A  
ENCOMPASS IDEAS INTERIOR  
DESIGN) UNTIL ALL PLANS ARE  
PAID FOR.

**S & A Ting**  
Wgtn Braces Waiting Lounge  
121 Thorndon Quay  
Wellington

3D  
VIEW V2 & 2A  
Lighting Plan  
31/10/22  
ISSUED: 8 February 2022  
REVISION #: PROJECT #:

SHEET REV


2



SHAW DAPPLE CARPET



ECC GERVASONI LIGHTS

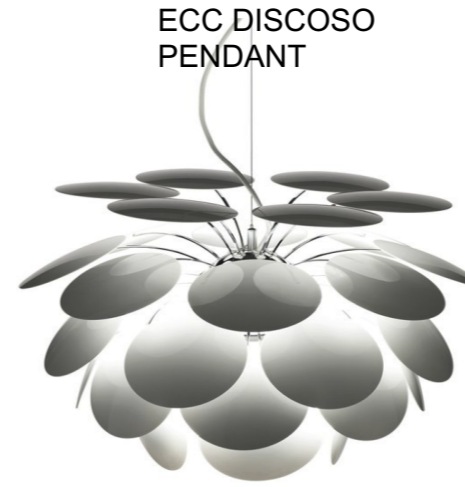


ECC DISCOSO PENDANT



TIMBER SLATTED SCREENS - LOW HEIGHT VERSION MAY MAKE WAITING LOUNGE FEEL LIKE A CORRAL.

GENERAL COLOUR PALETTE CUED OFF RUG BUT WARMED UP WITH ACCENT COLOURS

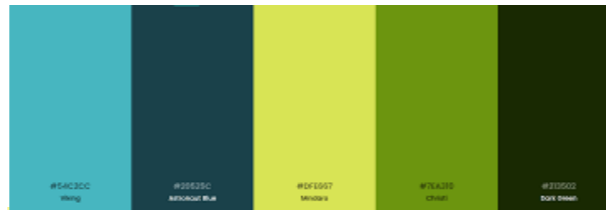


BOWIE ARMCHAIR



DS HUDSON COFFEE TABLE



BOBBY POUFE

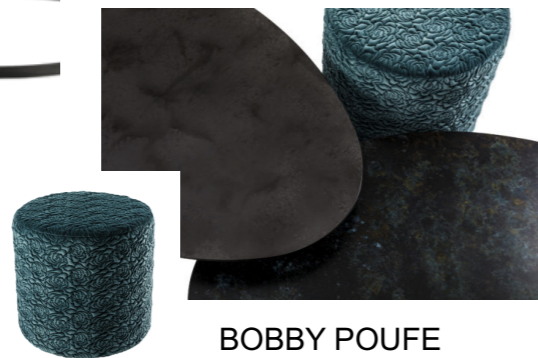

FLYNN SOFA 2.5M L 3 SEATER

ENCOMPASS IDEAS  
INTERIOR DESIGN  
Simone van der Plas PDINZ  
28 Arcus Rd RD2 Te Horo  
Otaki 5582  
PHONE: 021 5 999 55  
simone@eideas.co.nz  
www.eideas.co.nz



ALL DIMENSIONS ARE TO BE VERIFIED  
ONSITE. CONSTRUCTION TO COMPLY  
WITH CURRENT NZ BUILDING CODE &  
NZS:3604. OWNERSHIP OF PLANS AND  
DESIGN COPYRIGHT BELONGS TO  
ENCOMPASS GROUP LTD (T/A  
ENCOMPASS IDEAS INTERIOR DESIGN)  
UNTIL ALL PLANS ARE PAID FOR.

S & A Ting  
Wgtn Braces Waiting Lounge  
121 Thorndon Quay  
Wellington


SHEET TITLE: IMAGE BOARD  
FURNISHINGS & COLOURS  
REVISION #:  
ISSUED: 31/10/22  
PROJECT #: #PIn

SHEET  
REV

3

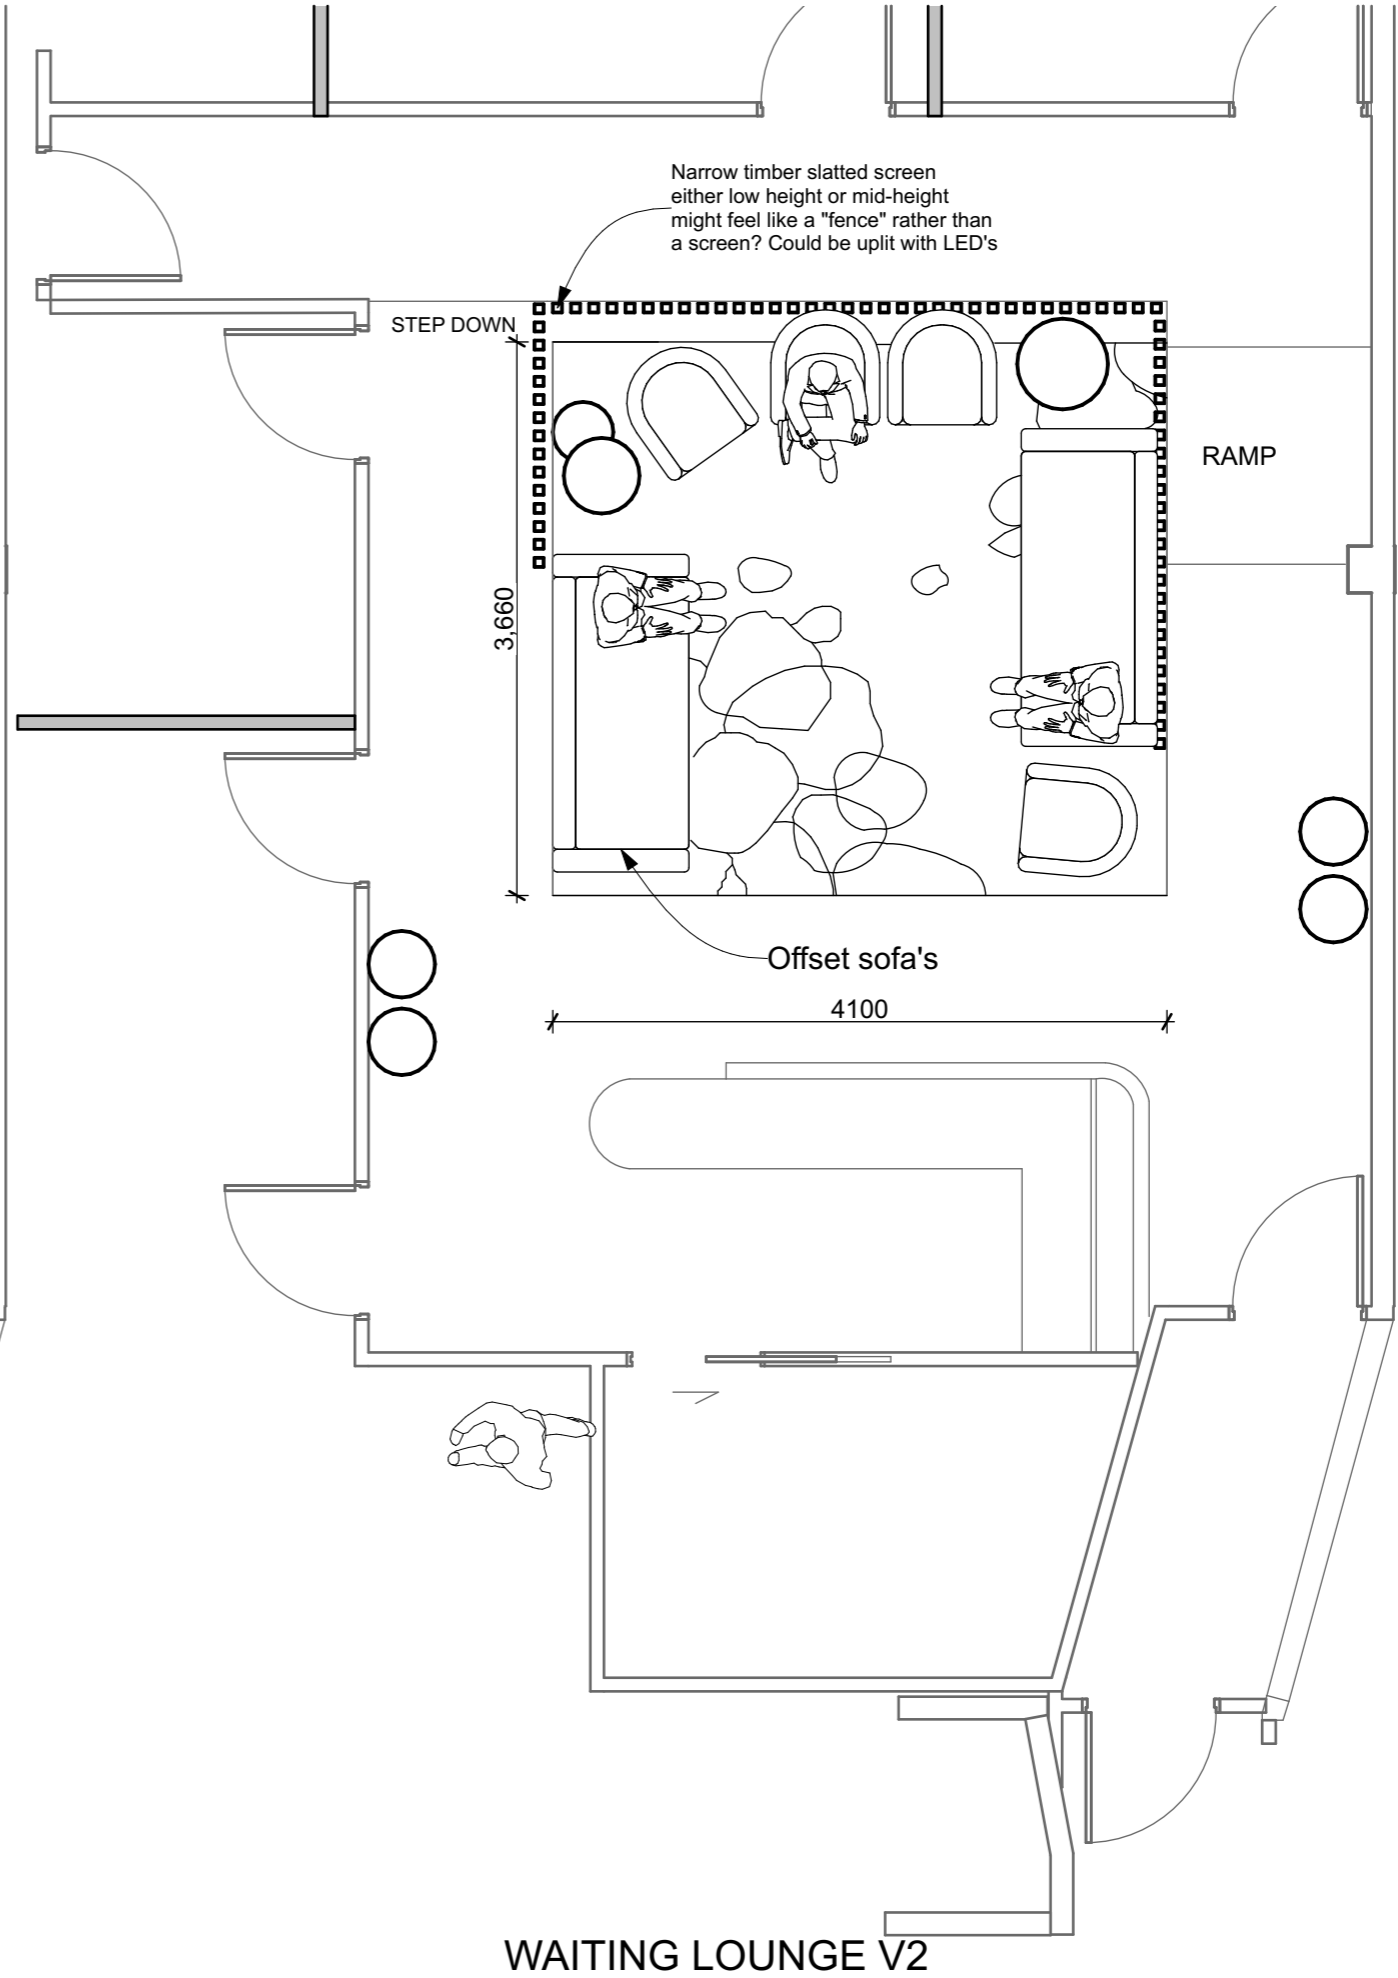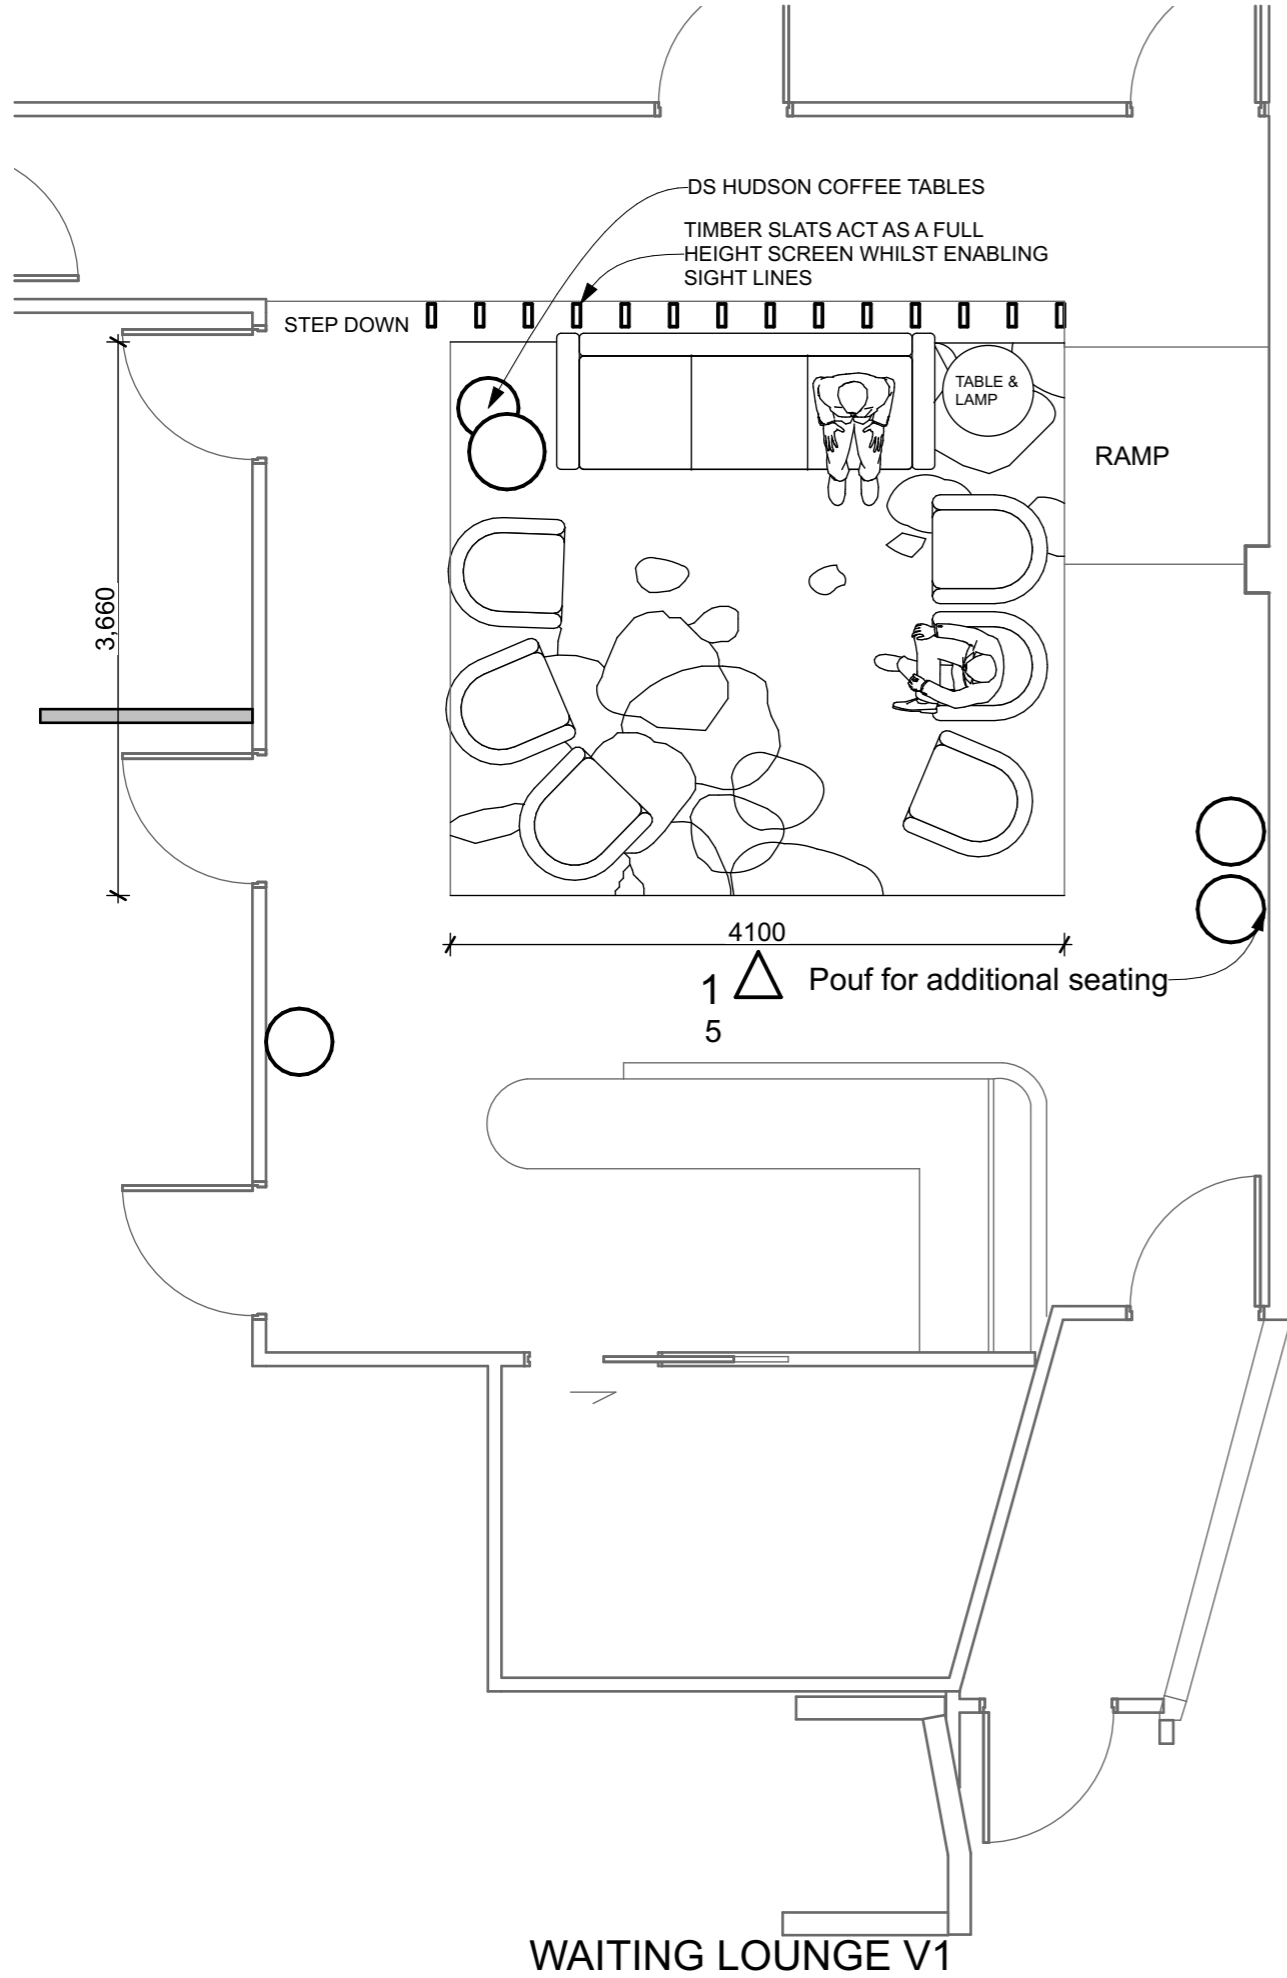


SHEET REV	SHEET TITLE: Waiting Area Floorplan Options V1&V2	S & A Ting Wgtn Braces Waiting Lounge 121 Thorndon Quay Wellington	ENCOMPASS IDEAS INTERIOR DESIGN Simone van der Plas PDINZ 28 Arcus Rd RD2 Te Horo Otaki 5582 PHONE: 021 5 999 55 simone@eideas.co.nz www.eideas.co.nz
	REVISION #:		ALL DIMENSIONS ARE TO BE VERIFIED ONSITE. CONSTRUCTION TO COMPLY WITH CURRENT NZ BUILDING CODE & NZS:3604. OWNERSHIP OF PLANS AND DESIGN COPYRIGHT BELONGS TO ENCOMPASS GROUP LTD (T/A ENCOMPASS IDEAS INTERIOR DESIGN) UNTIL ALL PLANS ARE PAID FOR.
	ISSUED: 31/10/22		
	PROJECT #: _____		
			#P/n
			<b>4</b>

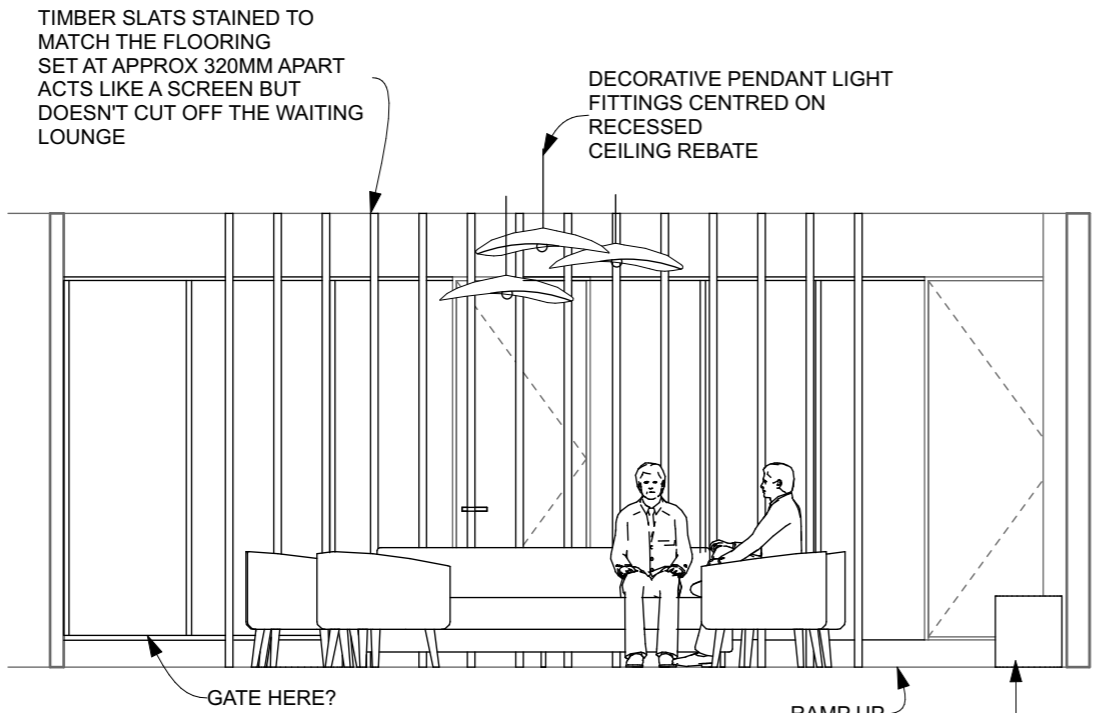

WAITING AREA V1

RAMP UP  
 ADDITIONAL POUF  
 LOCATED AROUND  
 PERIPHERAL  
 AREA TO PROVIDE  
 ADDITIONAL SEATING IF  
 REQ'D

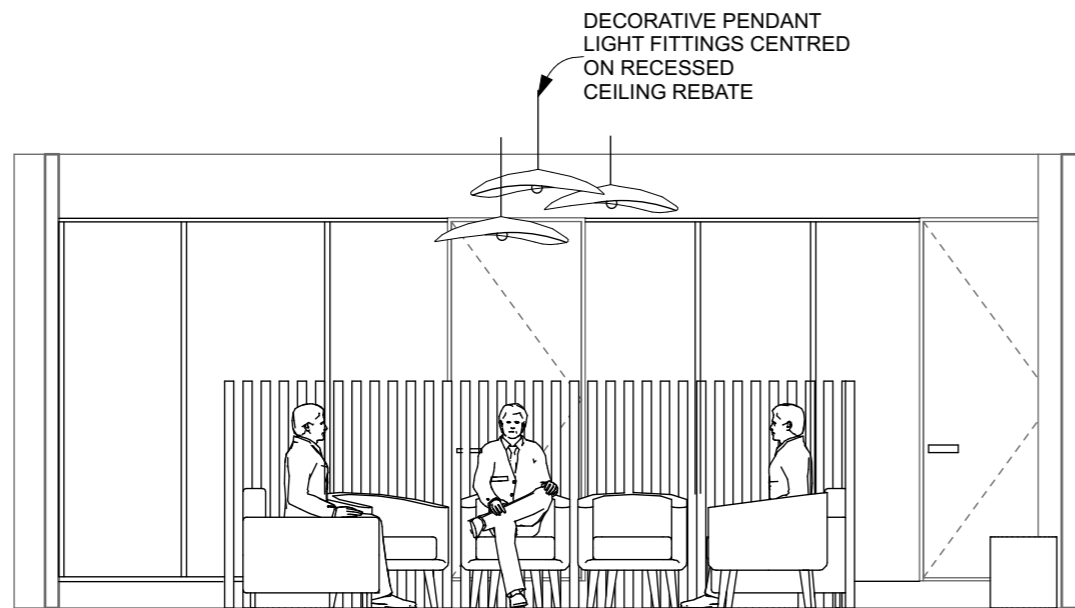

WAITING AREA V2



ENCOMPASS IDEAS  
 INTERIOR DESIGN  
 Simone van der Plas PDINZ  
 28 Arcus Rd RD2 Te Horo  
 Otaki 5682  
 PHONE: 021 5 999 55  
 simone@eidideas.co.nz  
 www.eidideas.co.nz

ALL DIMENSIONS ARE TO BE VERIFIED  
 ON SITE. CONSTRUCTION TO COMPLY  
 WITH CURRENT NZ BUILDING CODE &  
 NZS:3604. OWNERSHIP OF PLANS AND  
 DESIGN COPYRIGHT BELONGS TO  
 ENCOMPASS GROUP LTD (T/A  
 ENCOMPASS IDEAS INTERIOR DESIGN)  
 UNTIL ALL PLANS ARE PAID FOR.

**S & A Ting**  
**Wgtn Braces Waiting Lounge**  
 121 Thorndon Quay  
 Wellington

SHEET TITLE: Elevations V1 & V2  
 REVISION #:  
 ISSUED: 31/10/22  
 PROJECT #: #P/n